

THIS DRAWING IS THE PROPERTY OF THE DESIGN ASSOCIATES INC. AND SHALL NOT BE COPIED OR USED IN ANY MANNER WITHOUT PRIOR PERMISSION.

NOTES:-

1. ALL DIMENSIONS ARE IN MM.
2. ALL DIMENSIONS ARE TO BE READ AND NOT MEASURED.
3. ALL LEVELS ARE IN MM.
4. GRID DIMENSIONS AND PLOT LINES ARE TO BE STRICTLY ADHERED TO.
5. ALL LEVELS INCLUDING FLOOR LEVELS, CILL & LINTEL LEVELS, LANDING LEVELS, PARAPET HEIGHT/ LEVELS, LEVELS OF HORIZONTAL PROJECTION & BONDS INCLUDING ANY SURFACE FEATURES INDICATED IN THE DRAWINGS ARE TO BE STRICTLY ADHERED TO.

MARK	DATE	DESCRIPTION

MEP CONSULTANT-
ARK CONSULTANTS
 1/30 ROSHAN GARDEN-II
 KAKROLA ROAD NAJAFGARH
 NEW DELHI-110043
 MOB:- 9599932606,9599932706
 E-MAIL-ark.mep2006@gmail.com

STRUCTURE CONSULTANT-
 CE CON ENGG.
 NEW DELHI

ARCHITECTS-
DESIGN ASSOCIATES INC.
 ARCHITECTURE
 A-163, Sector-136, Noida 201301
 PH. :0120-2428600, Fax: 0120-4778530
 e-mail: sachin.agarwal@designassociates.in


PROJECT-
 COMMERCIAL COMPLEX
 AT POLO MARKET
 SHILLONG

DRAWING TITLE-
 STILT FLOOR PLAN
 (PLUMBING)

DRAWING PURPOSE-
 FOR TENDER PURPOSES ONLY

JOB NO. -	DWG. REF. NO. -	DATE- 05.10.2019
SCALE- 1:100	REVISION- ---	DATE OF ISSUE- ---

DWG. NO. - PM/CD/PL/101	
SHEET SIZE- A3	SHEET NO- 01/01
DRAWN BY- V.K	CHECKED BY- A.G

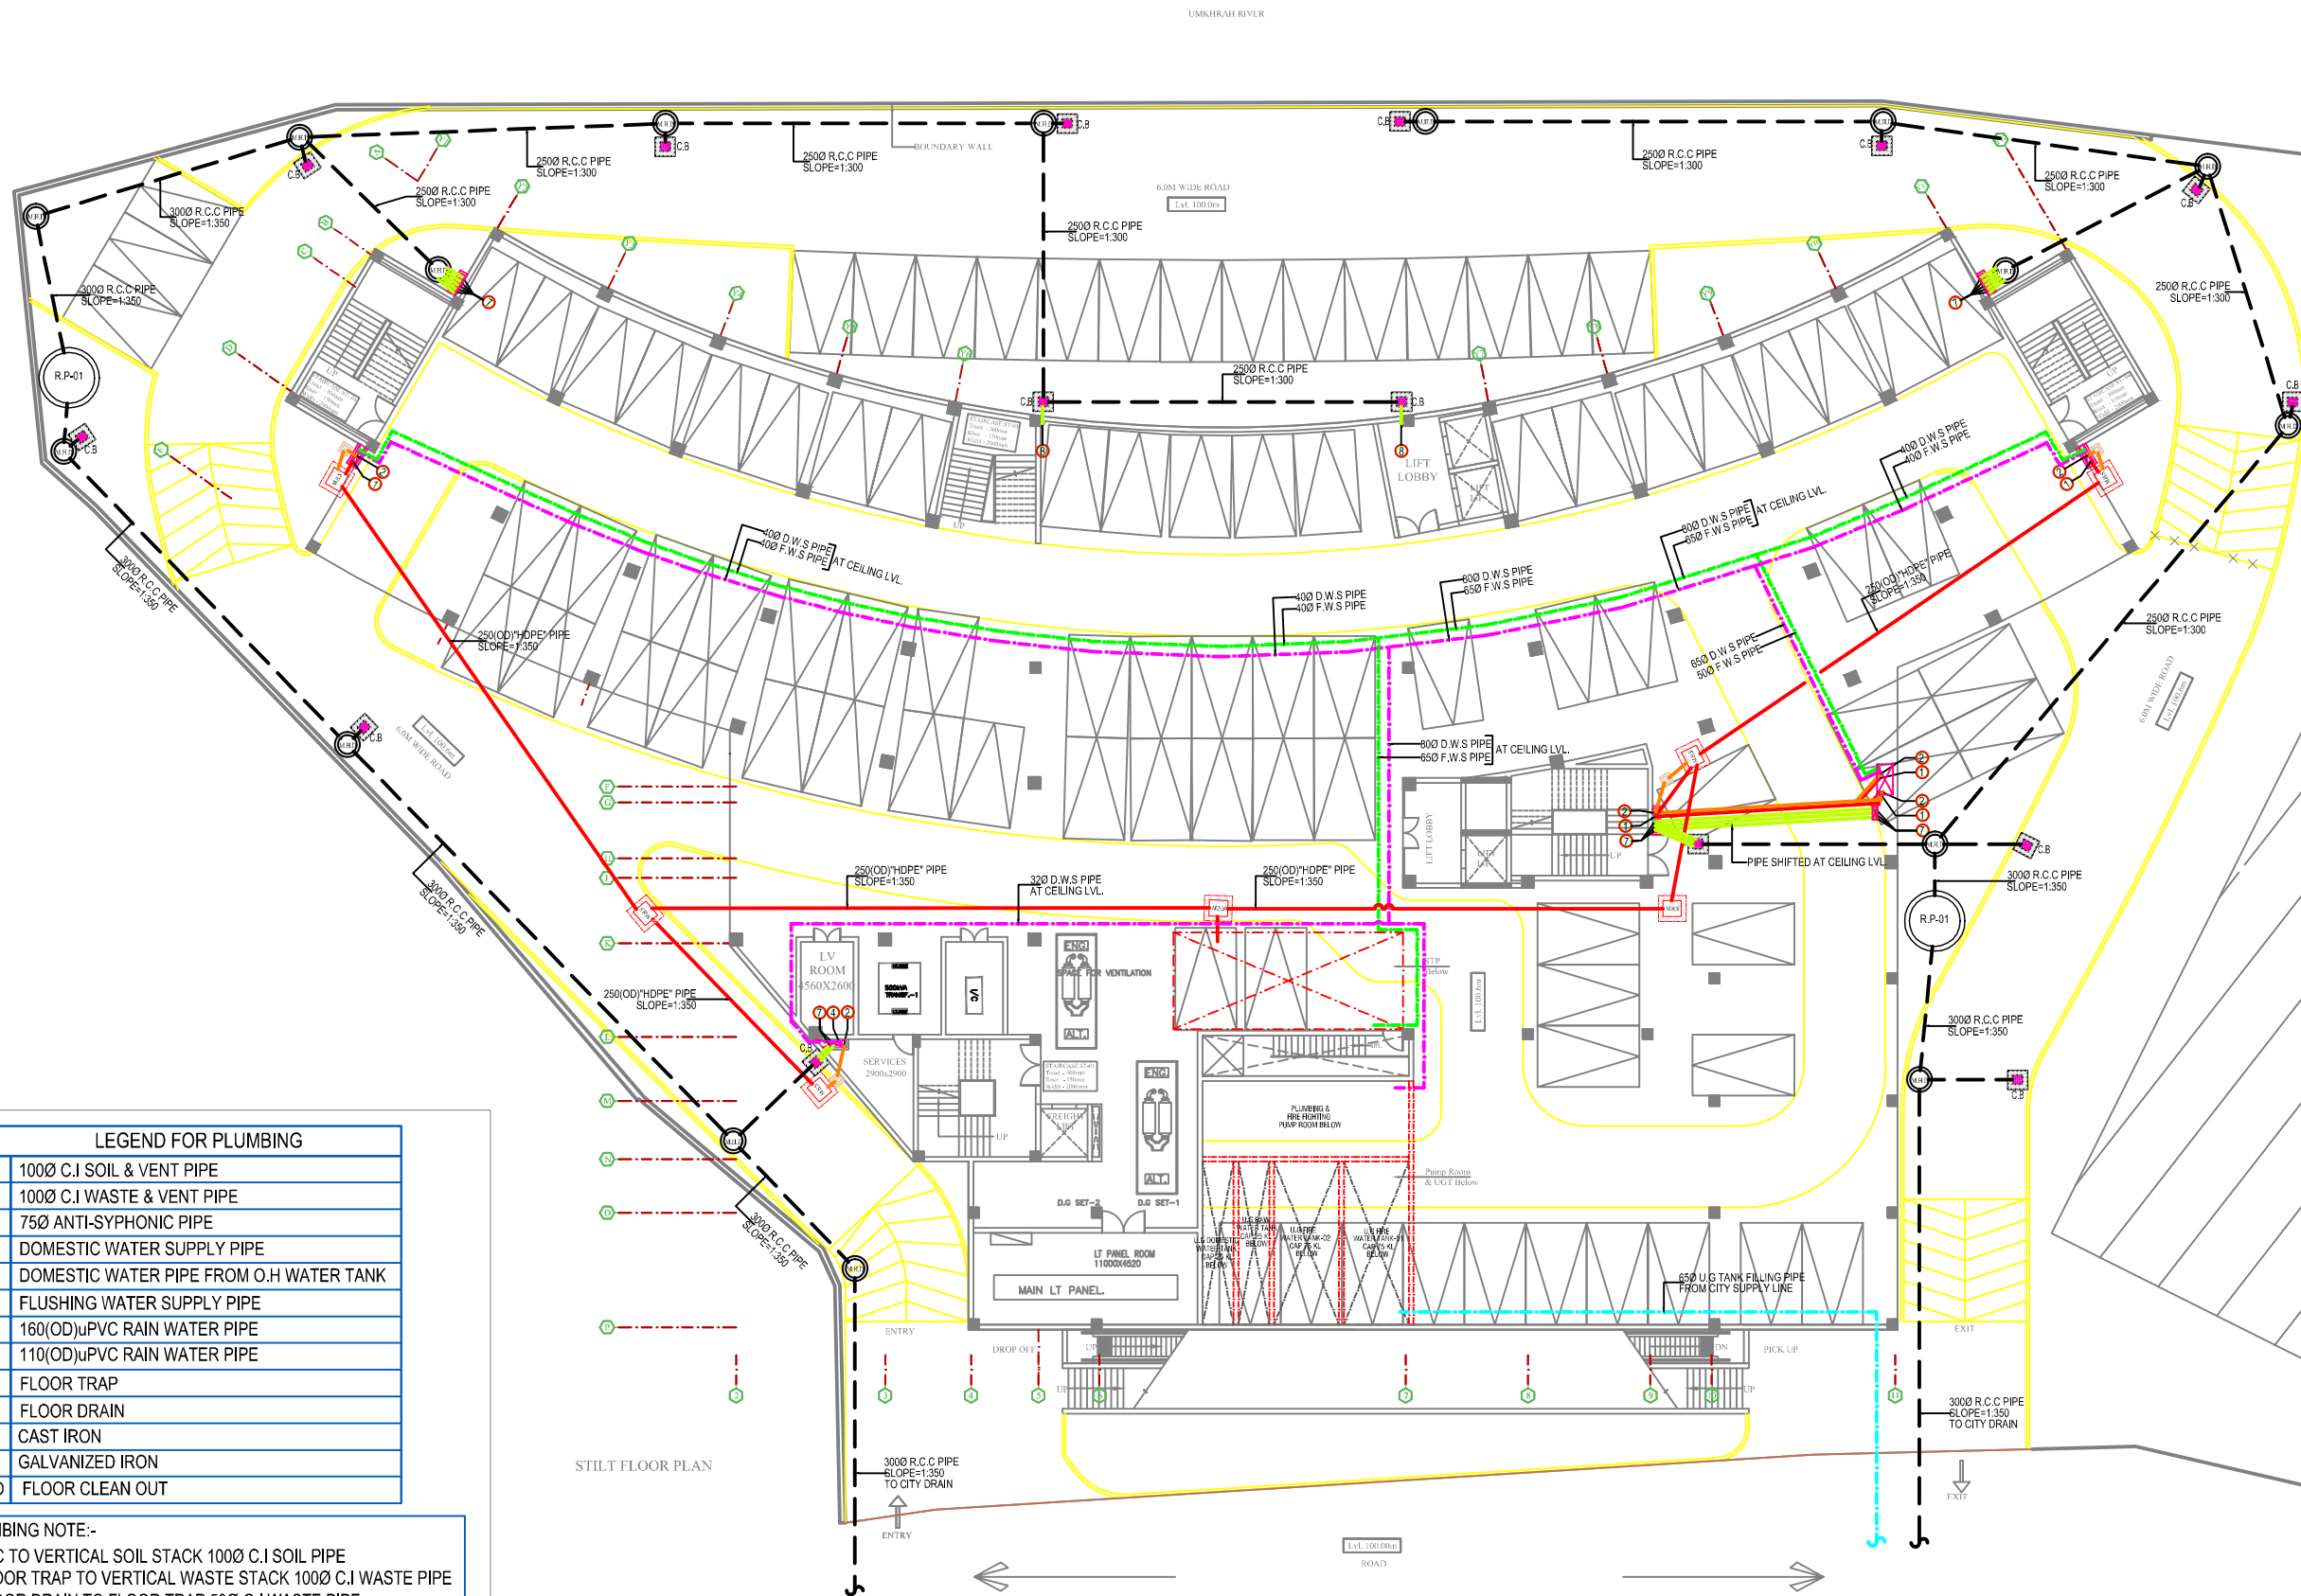

LEGEND FOR PLUMBING

①	1000 C.I SOIL & VENT PIPE
②	1000 C.I WASTE & VENT PIPE
③	750 ANTI-SYPHONIC PIPE
④	DOMESTIC WATER SUPPLY PIPE
⑤	DOMESTIC WATER PIPE FROM O.H WATER TANK
⑥	FLUSHING WATER SUPPLY PIPE
⑦	160(OD)uPVC RAIN WATER PIPE
⑧	110(OD)uPVC RAIN WATER PIPE
F.T	FLOOR TRAP
F.D	FLOOR DRAIN
C.I	CAST IRON
G.I	GALVANIZED IRON
F.C.O	FLOOR CLEAN OUT

PLUMBING NOTE:-

- * W.C TO VERTICAL SOIL STACK 1000 C.I SOIL PIPE
- * FLOOR TRAP TO VERTICAL WASTE STACK 1000 C.I WASTE PIPE
- * FLOOR DRAIN TO FLOOR TRAP 500 G.I WASTE PIPE
- * WASH BASIN TO FLOOR TRAP 320 G.I WASTE PIPE
- * ALL WATER SUPPLY PIPES RUNNING AT VERTICAL SHAFT, TERRACE LEVEL & RUNNING AT CEILING LEVEL SHALL BE G.I PIPES & FITTINGS.
- * ALL WATER SUPPLY PIPES WITH IN THE TOILET, IN WALL, CHASES SHALL BE "CPVC" PIPES & FITTINGS.
- * ALL VALVE UP TO 40mm DIA SHALL BE BALL VALVE.
- * ALL VALVE 50mm DIA & ABOVE SHALL BE BUTTER FLY VALVE.



THIS DRAWING IS THE PROPERTY OF THE DESIGN ASSOCIATES INC. AND SHALL NOT BE COPIED OR USED IN ANY MANNER WITHOUT PRIOR PERMISSION.

NOTES:-

- ALL DIMENSIONS ARE IN MM.
- ALL DIMENSIONS ARE TO BE READ AND NOT MEASURED.
- ALL LEVELS ARE IN MM.
- GRID DIMENSIONS AND PLOT LINES ARE TO BE STRICTLY ADHERED TO.
- ALL LEVELS INCLUDING FLOOR LEVELS, CILL & LINTEL LEVELS, LANDING LEVELS, PARAPET HEIGHT/ LEVELS, LEVELS OF HORIZONTAL PROJECTION & BONDS INCLUDING ANY SURFACE FEATURES INDICATED IN THE DRAWINGS ARE TO BE STRICTLY ADHERED TO.

MARK	DATE	DESCRIPTION

MEP CONSULTANT-
ARK CONSULTANTS
 1/30 ROSHAN GARDEN-II
 KAKROLA ROAD NAJAFGARH
 NEW DELHI-110043
 MOB:- 9599932606,9599932706
 E-MAIL-ark.mep2006@gmail.com

STRUCTURE CONSULTANT-
 CE CON ENGG.
 NEW DELHI

ARCHITECTS-
DESIGN ASSOCIATES INC.
 ARCHITECTS
 A-163, Sector-136, Noida 201301
 PH. :0120-2428600, Fax: 0120-4778530
 e-mail: sachin.agarwal@designassociates.in

PROJECT-
 COMMERCIAL COMPLEX
 AT POLO MARKET
 SHILLONG


DRAWING TITLE-
 FIRST FLOOR PLAN
 (PLUMBING)

DRAWING PURPOSE-
 FOR TENDER PURPOSES ONLY

JOB NO. -	DWG. REF. NO. -	DATE-
---	---	05.10.2019
SCALE-	REVISION-	DATE OF ISSUE-
1:100	---	---

DWG. NO.-
 PM/CD/PL/103

SHEET SIZE-	A3	SHEET NO.-	01/01
	DRAWN BY-	CHECKED BY-	
	V.K		A.G

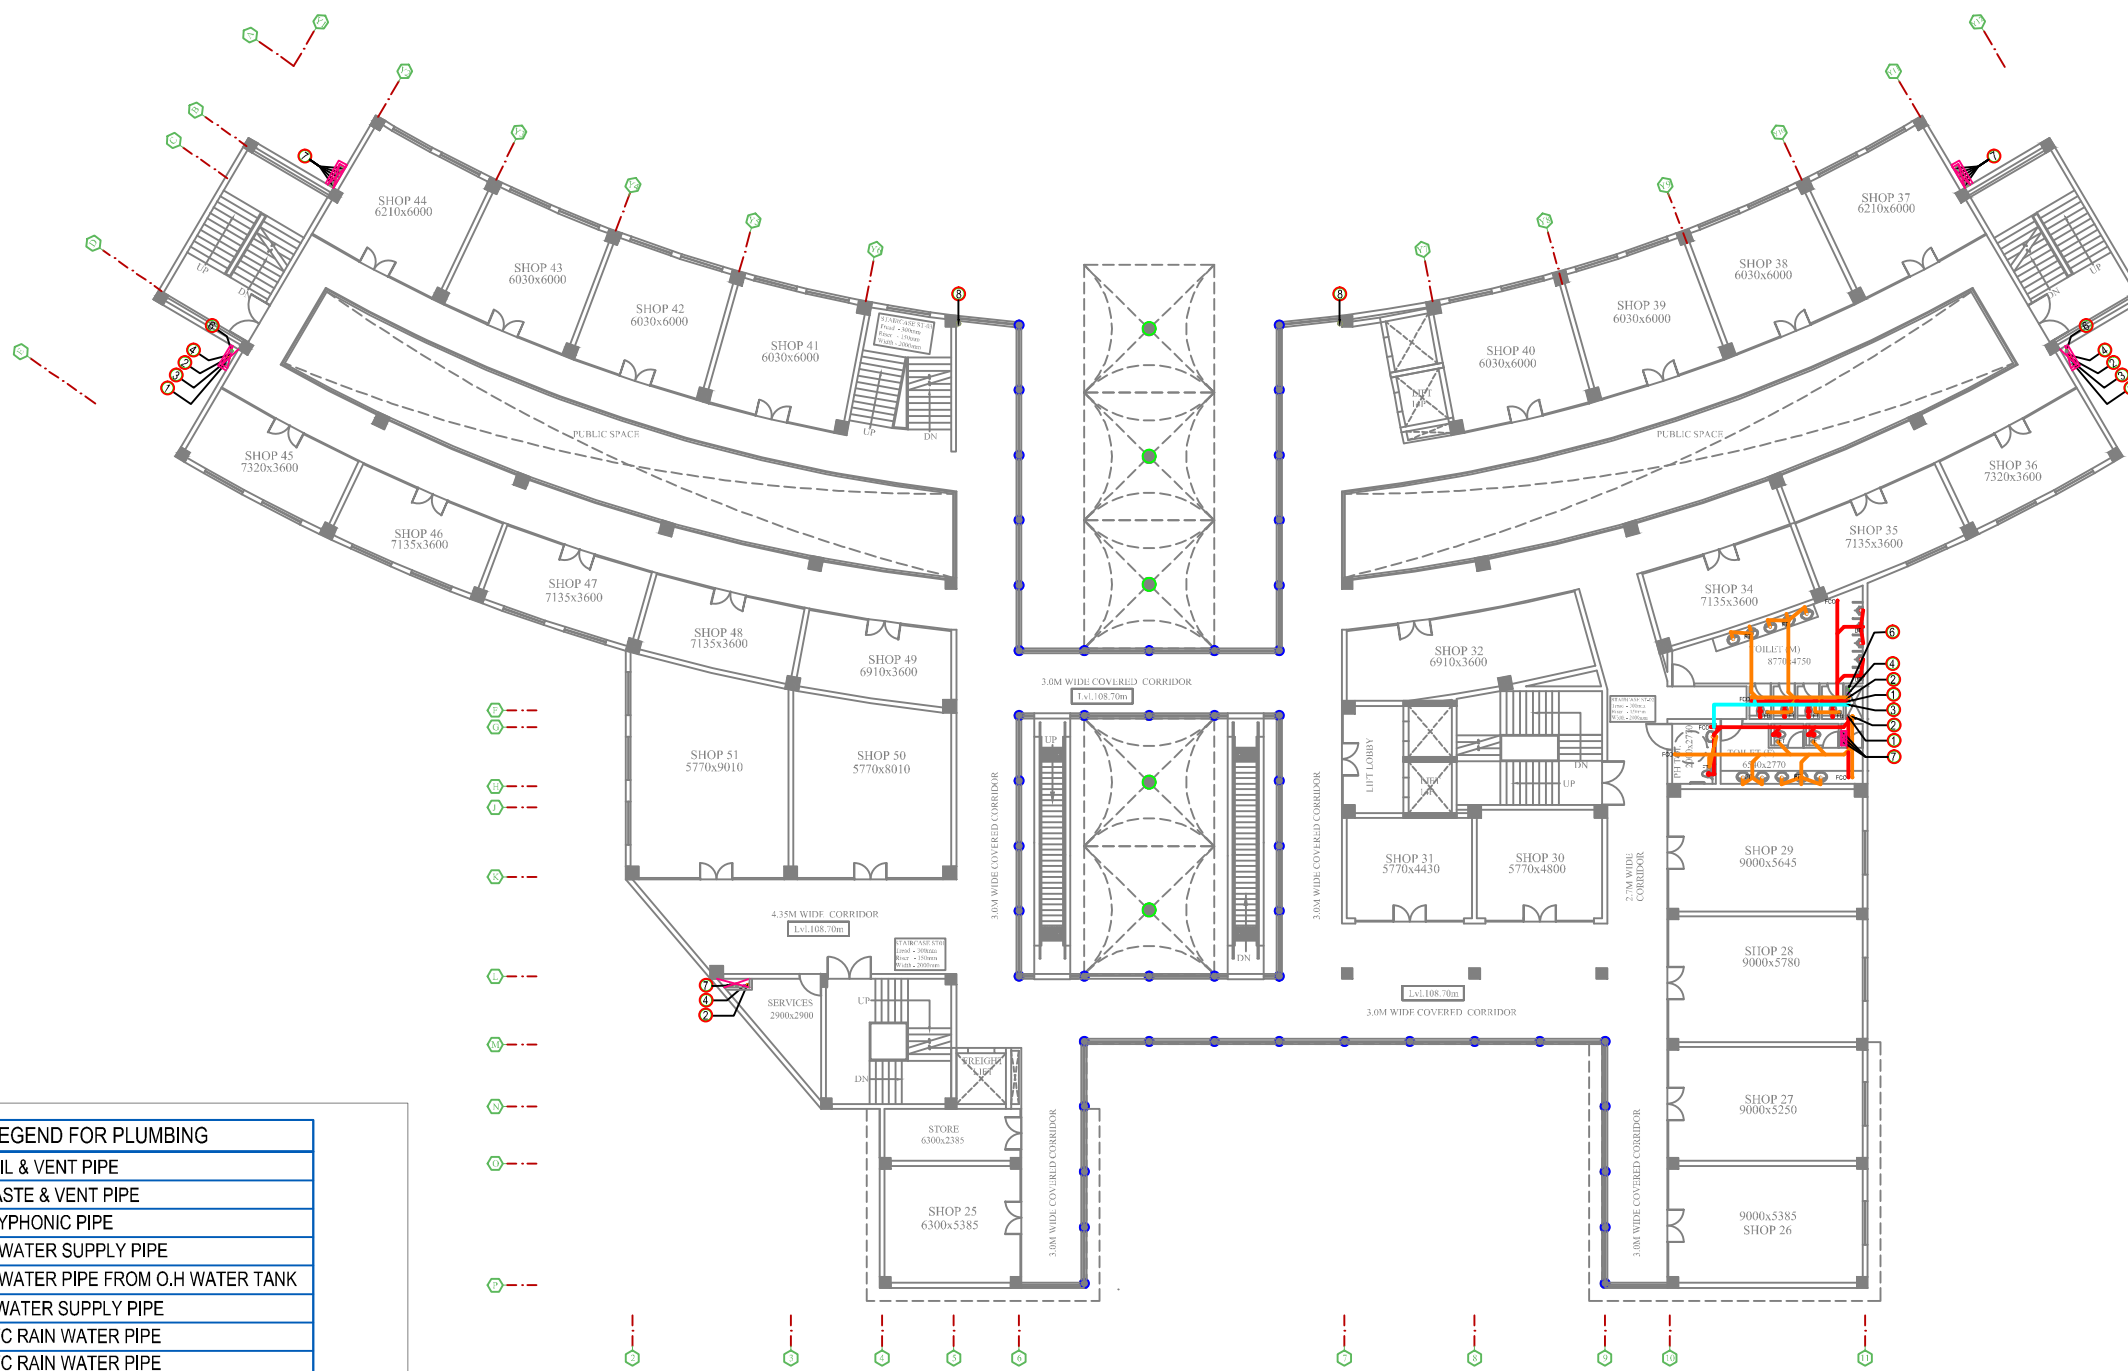

FIRST FLOOR PLAN

LEGEND FOR PLUMBING	
①	100Ø C.I SOIL & VENT PIPE
②	100Ø C.I WASTE & VENT PIPE
③	75Ø ANTI-SYPHONIC PIPE
④	DOMESTIC WATER SUPPLY PIPE
⑤	DOMESTIC WATER PIPE FROM O.H WATER TANK
⑥	FLUSHING WATER SUPPLY PIPE
⑦	160(OD)uPVC RAIN WATER PIPE
⑧	110(OD)uPVC RAIN WATER PIPE
F.T	FLOOR TRAP
F.D	FLOOR DRAIN
C.I	CAST IRON
G.I	GALVANIZED IRON
F.C.O	FLOOR CLEAN OUT

PLUMBING NOTE:-
 * W.C TO VERTICAL SOIL STACK 100Ø C.I SOIL PIPE
 * FLOOR TRAP TO VERTICAL WASTE STACK 100Ø C.I WASTE PIPE
 * FLOOR DRAIN TO FLOOR TRAP 50Ø G.I WASTE PIPE
 * WASH BASIN TO FLOOR TRAP 32Ø G.I WASTE PIPE
 * ALL WATER SUPPLY PIPES RUNNING AT VERTICAL SHAFT, TERRACE LEVEL & RUNNING AT CEILING LEVEL SHALL BE G.I PIPES & FITTINGS.
 * ALL WATER SUPPLY PIPES WITH IN THE TOILET, IN WALL, CHASES SHALL BE "CPVC" PIPES & FITTINGS.
 * ALL VALVE UP TO 40mm DIA SHALL BE BALL VALVE.
 * ALL VALVE 50mm DIA & ABOVE SHALL BE BUTTER FLY VALVE.



THIS DRAWING IS THE PROPERTY OF THE DESIGN ASSOCIATES INC. AND SHALL NOT BE COPIED OR USED IN ANY MANNER WITHOUT PRIOR PERMISSION.

NOTES:-

1. ALL DIMENSIONS ARE IN MM.
2. ALL DIMENSIONS ARE TO BE READ AND NOT MEASURED.
3. ALL LEVELS ARE IN MM.
4. GRID DIMENSIONS AND PLOT LINES ARE TO BE STRICTLY ADHERED TO.
5. ALL LEVELS INCLUDING FLOOR LEVELS, CILL & LINTEL LEVELS, LANDING LEVELS, PARAPET HEIGHT/ LEVELS, LEVELS OF HORIZONTAL PROJECTION & BONDS INCLUDING ANY SURFACE FEATURES INDICATED IN THE DRAWINGS ARE TO BE STRICTLY ADHERED TO.

MARK	DATE	DESCRIPTION

MEP CONSULTANT-
ARK CONSULTANTS
 1/30 ROSHAN GARDEN-II
 KAKROLA ROAD NAJAFGARH
 NEW DELHI-110043
 MOB:- 9599932606,9599932706
 E-MAIL-ark.mep2006@gmail.com

STRUCTURE CONSULTANT-
 CE CON ENGG.
 NEW DELHI

ARCHITECTS-
DESIGN ASSOCIATES INC.
 ARCHITECTURE
 A-163, Sector-136, Noida 201301
 PH. :0120-2428600, Fax: 0120-4778530
 e-mail: sachin.agarwal@designassociates.in

PROJECT-
 COMMERCIAL COMPLEX
 AT POLO MARKET
 SHILLONG

DRAWING TITLE-
 SECOND FLOOR PLAN
 (PLUMBING)


DRAWING PURPOSE-
 FOR TENDER PURPOSES ONLY

JOB NO. -	DWG. REF. NO. -	DATE -
---	---	05.10.2019

SCALE -	REVISION -	DATE OF ISSUE -
1:100	---	---

DWG. NO. -	SHEET NO. -
PM/CD/PL/104	A3

DRAWN BY -	CHECKED BY -
V.K	A.G

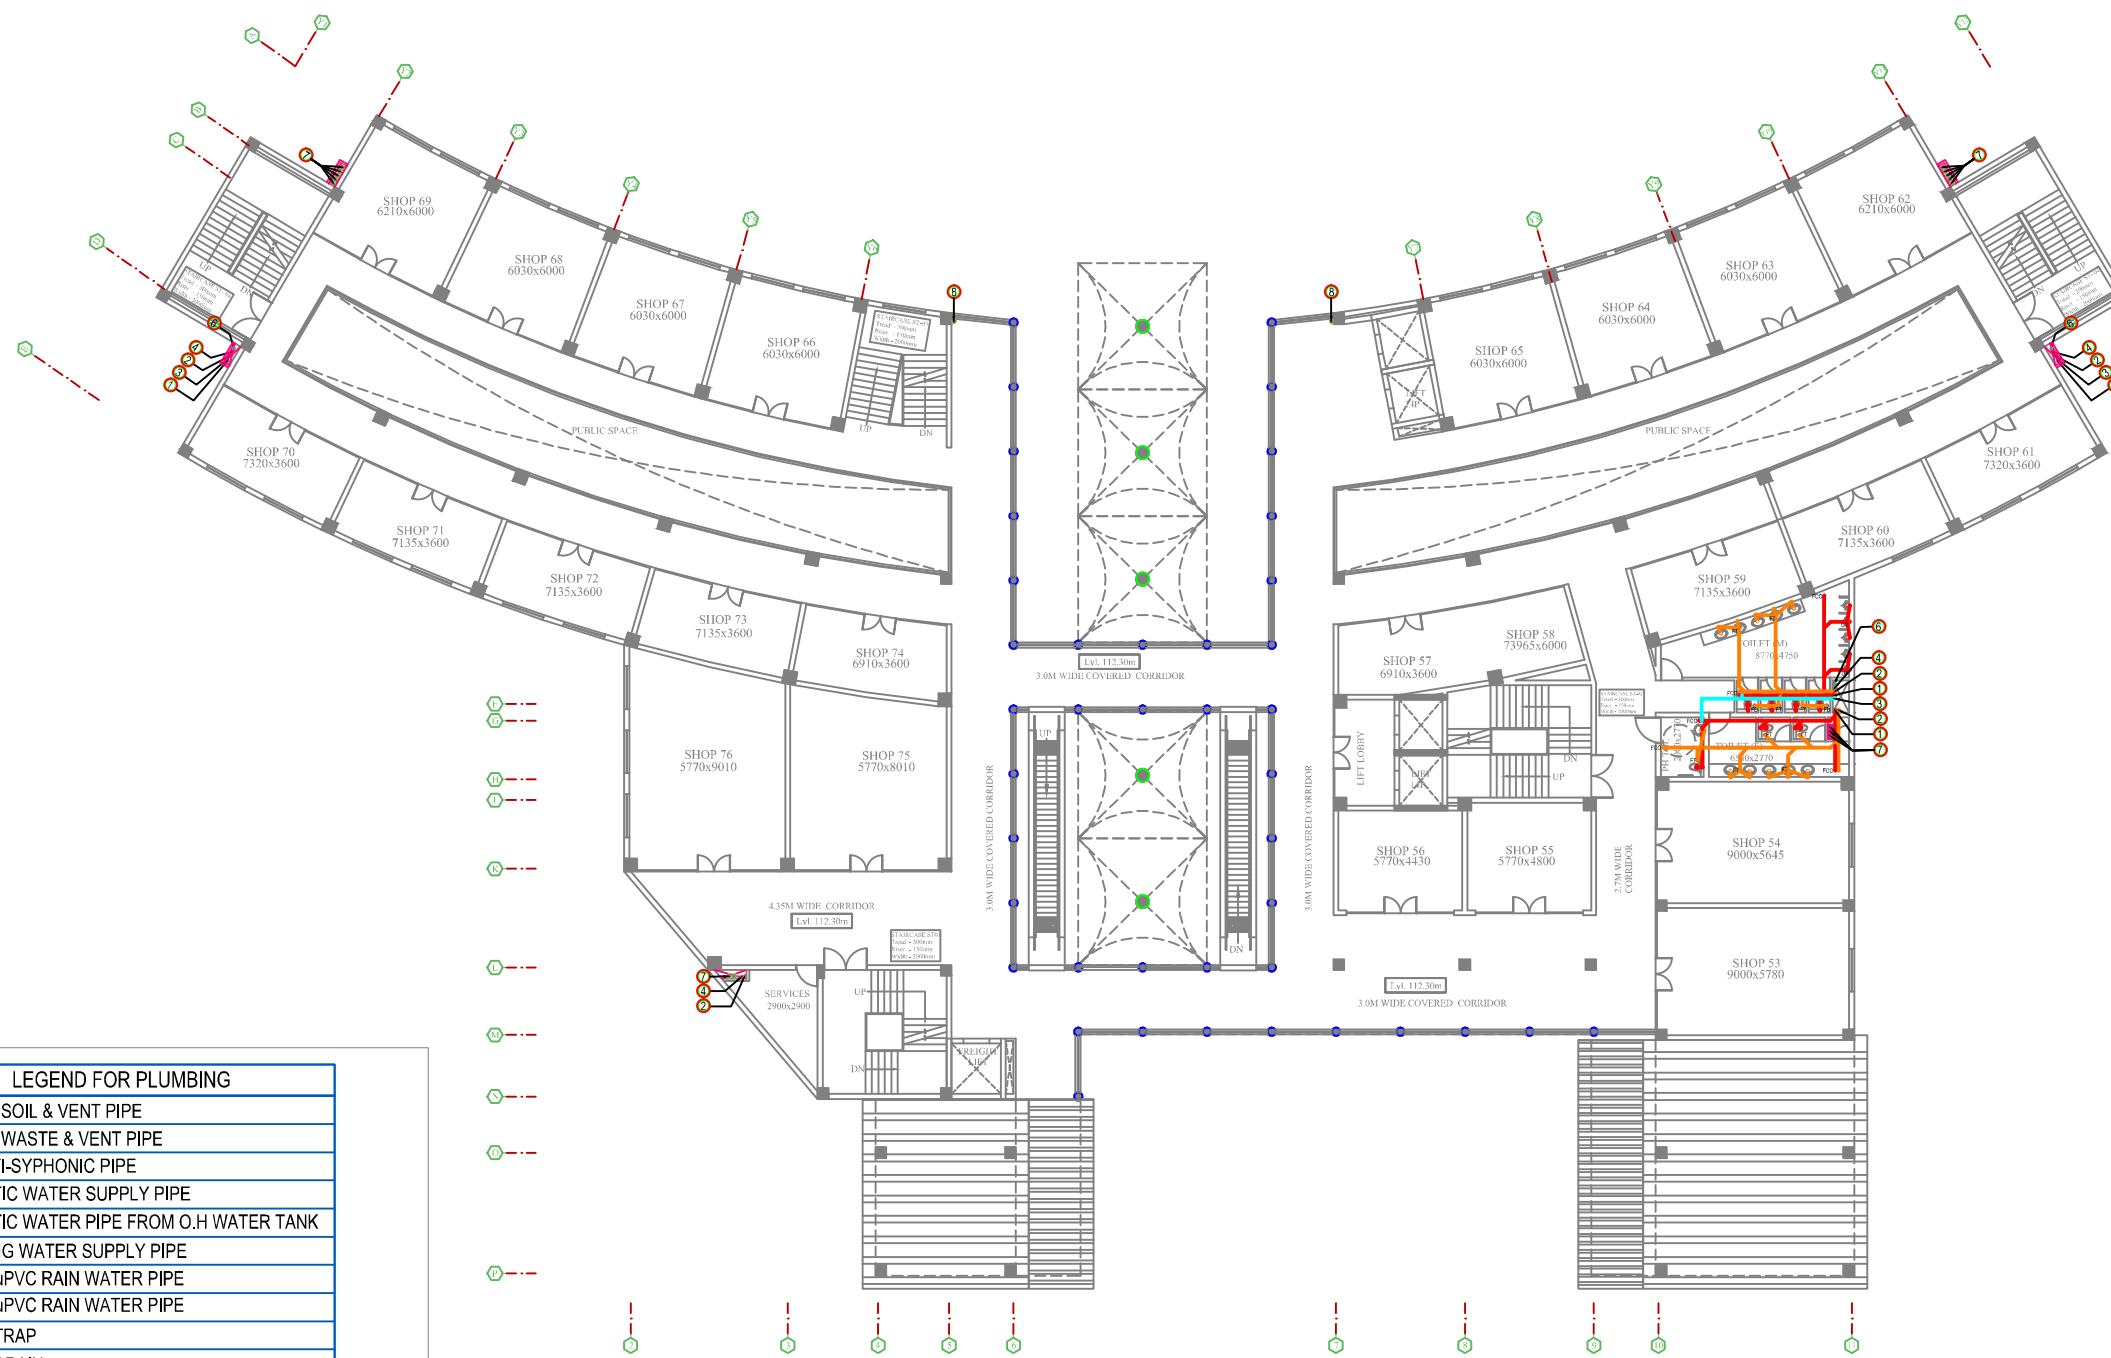

SECOND FLOOR PLAN

LEGEND FOR PLUMBING	
①	100Ø C.I SOIL & VENT PIPE
②	100Ø C.I WASTE & VENT PIPE
③	75Ø ANTI-SYPHONIC PIPE
④	DOMESTIC WATER SUPPLY PIPE
⑤	DOMESTIC WATER PIPE FROM O.H WATER TANK
⑥	FLUSHING WATER SUPPLY PIPE
⑦	160(OD)uPVC RAIN WATER PIPE
⑧	110(OD)uPVC RAIN WATER PIPE
F.T	FLOOR TRAP
F.D	FLOOR DRAIN
C.I	CAST IRON
G.I	GALVANIZED IRON
F.C.O	FLOOR CLEAN OUT

PLUMBING NOTE:-
 * W.C TO VERTICAL SOIL STACK 100Ø C.I SOIL PIPE
 * FLOOR TRAP TO VERTICAL WASTE STACK 100Ø C.I WASTE PIPE
 * FLOOR DRAIN TO FLOOR TRAP 50Ø G.I WASTE PIPE
 * WASH BASIN TO FLOOR TRAP 32Ø G.I WASTE PIPE
 * ALL WATER SUPPLY PIPES RUNNING AT VERTICAL SHAFT , TERRACE LEVEL & RUNNING AT CEILING LEVEL SHALL BE G.I PIPES & FITTINGS.
 * ALL WATER SUPPLY PIPES WITH IN THE TOILET, IN WALL, CHASES SHALL BE "CPVC" PIPES & FITTINGS.
 * ALL VALVE UP TO 40mm DIA SHALL BE BALL VALVE.
 * ALL VALVE 50mm DIA & ABOVE SHALL BE BUTTER FLY VALVE.



THIS DRAWING IS THE PROPERTY OF THE DESIGN ASSOCIATES INC. AND SHALL NOT BE COPIED OR USED IN ANY MANNER WITHOUT PRIOR PERMISSION.

NOTES:-

1. ALL DIMENSIONS ARE IN MM.
2. ALL DIMENSIONS ARE TO BE READ AND NOT MEASURED.
3. ALL LEVELS ARE IN MM.
4. GRID DIMENSIONS AND PLOT LINES ARE TO BE STRICTLY ADHERED TO.
5. ALL LEVELS INCLUDING FLOOR LEVELS, CILL & LINTEL LEVELS, LANDING LEVELS, PARAPET HEIGHT/ LEVELS, LEVELS OF HORIZONTAL PROJECTION & BONDS INCLUDING ANY SURFACE FEATURES INDICATED IN THE DRAWINGS ARE TO BE STRICTLY ADHERED TO.

MARK	DATE	DESCRIPTION

MEP CONSULTANT-
ARK CONSULTANTS
 1/30 ROshan GARDEN-II
 KAKROLA ROAD NAJAFGARH
 NEW DELHI-110043
 MOB:- 9599932606,9599932706
 E-MAIL-ark.mep2006@gmail.com

STRUCTURE CONSULTANT-
 CE CON ENGG.
 NEW DELHI

ARCHITECTS-

 A-163, Sector-136, Noida 201301
 PH. :0120-2428600, Fax: 0120-4778530
 e-mail: sachin.agarwal@designassociates.in


PROJECT-
 COMMERCIAL COMPLEX
 AT POLO MARKET
 SHILLONG

DRAWING TITLE-
 THIRD FLOOR PLAN
 (PLUMBING)

DRAWING PURPOSE-
 FOR TENDER PURPOSES ONLY

JOB NO. -	DWG. REF. NO. -	DATE-
---	---	05.10.2019
SCALE-	REVISION-	DATE OF ISSUE-
1:100	---	---

DWG. NO. -		SHEET NO. -	
PM/CD/PL/105		01/01	
SHEET SIZE- A3		DRAWN BY- V.K	
DRAWN BY- V.K		CHECKED BY- A.G	

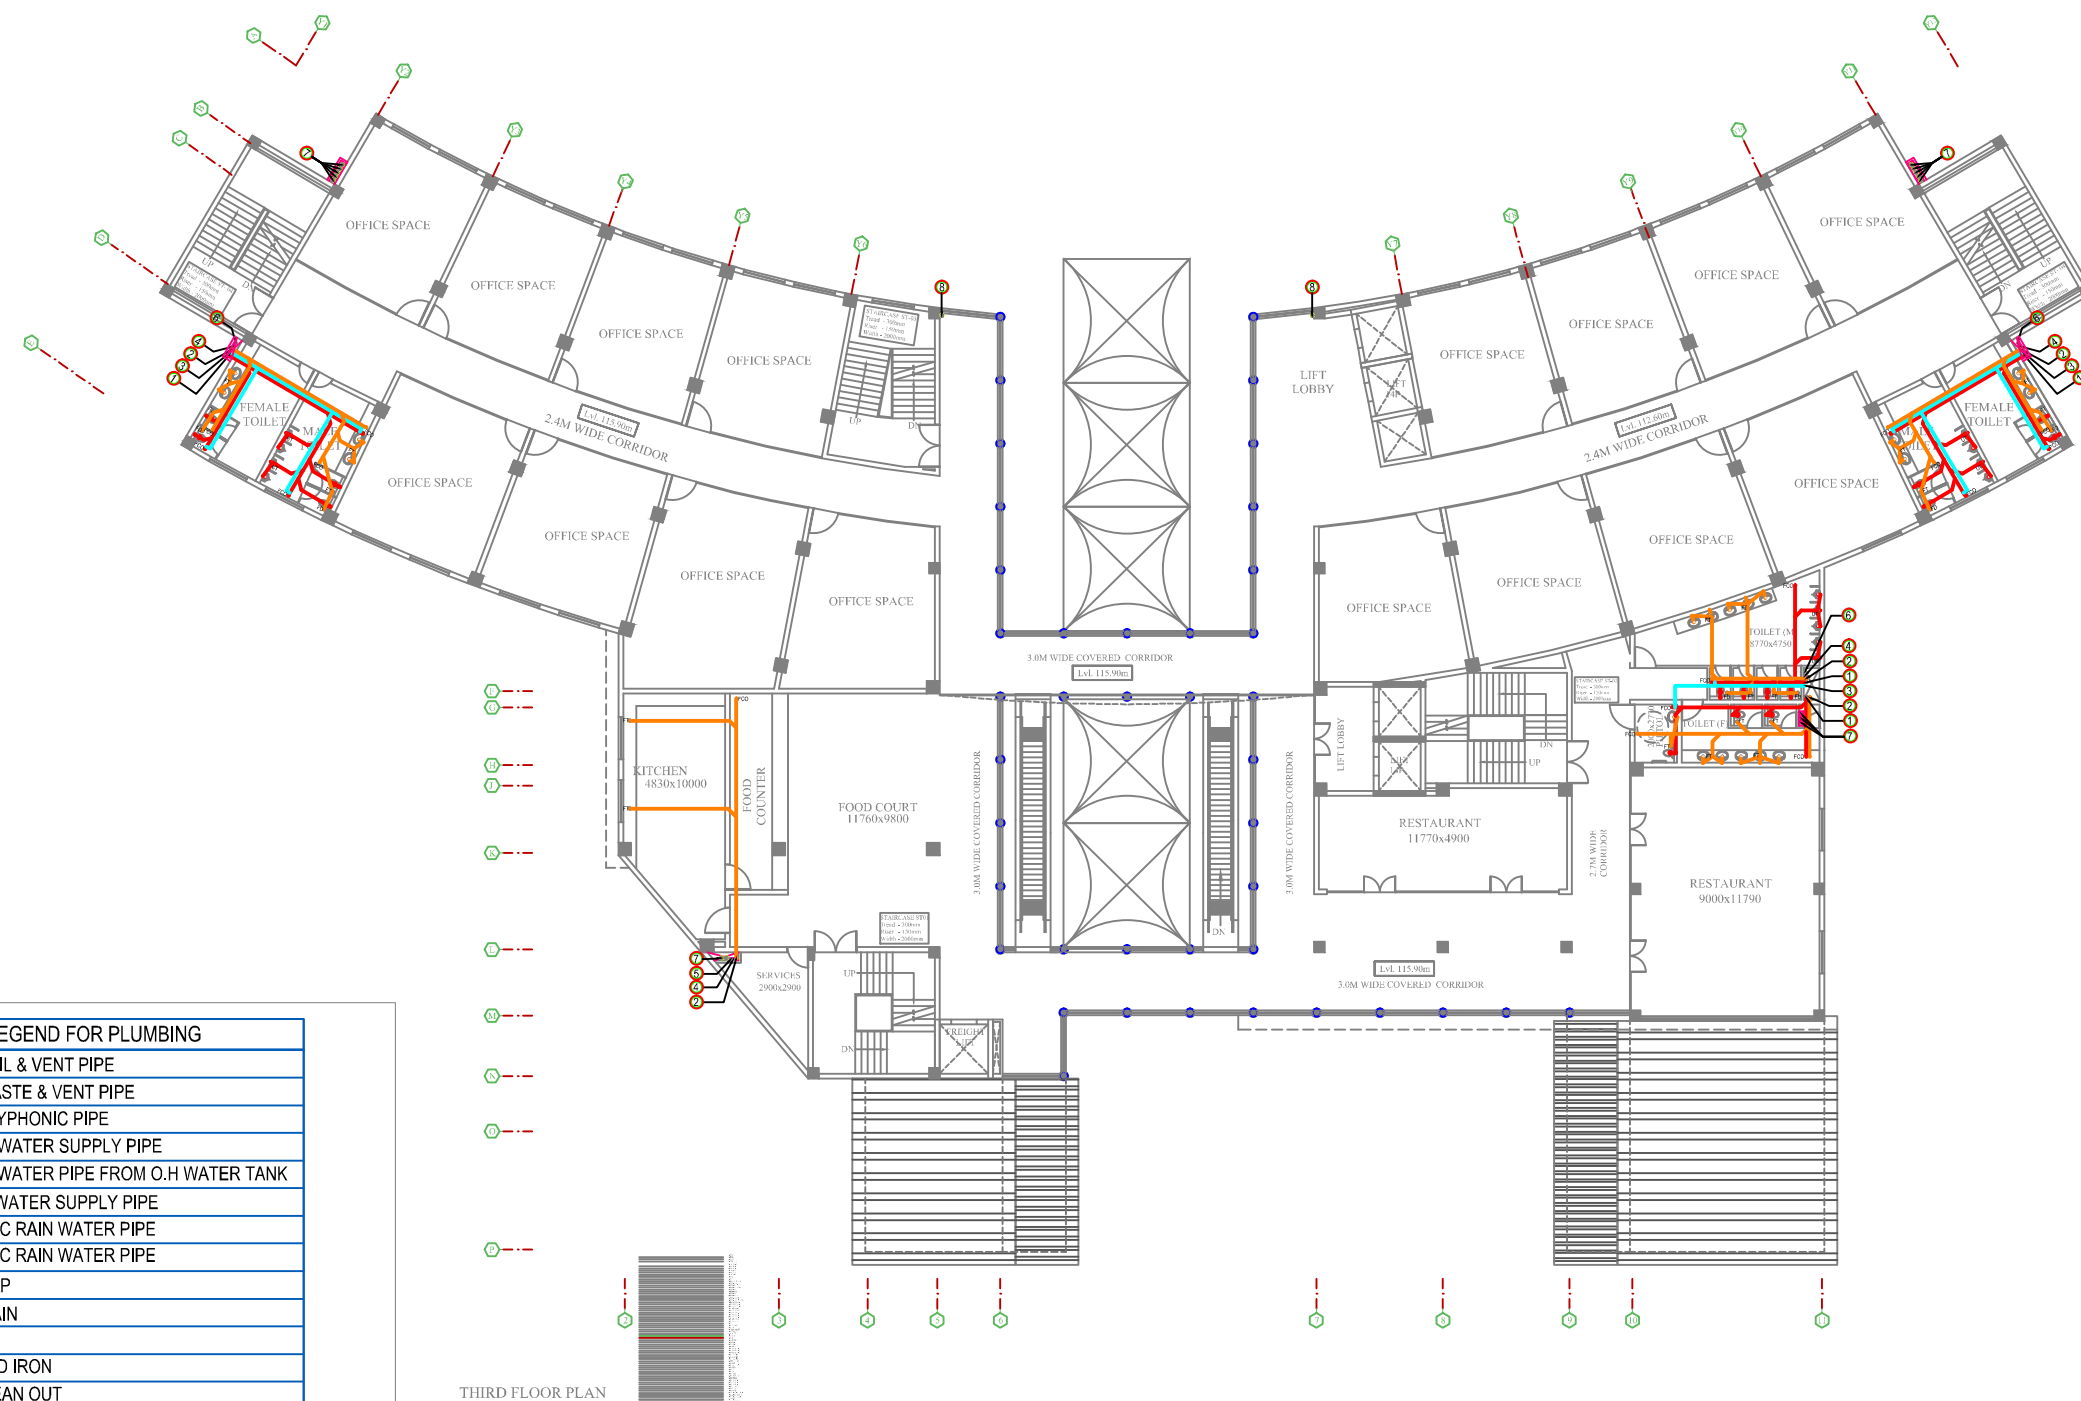

THIRD FLOOR PLAN

LEGEND FOR PLUMBING	
①	1000 C.I SOIL & VENT PIPE
②	1000 C.I WASTE & VENT PIPE
③	75Ø ANTI-SYPHONIC PIPE
④	DOMESTIC WATER SUPPLY PIPE
⑤	DOMESTIC WATER PIPE FROM O.H WATER TANK
⑥	FLUSHING WATER SUPPLY PIPE
⑦	160(OD)uPVC RAIN WATER PIPE
⑧	110(OD)uPVC RAIN WATER PIPE
F.T	FLOOR TRAP
F.D	FLOOR DRAIN
C.I	CAST IRON
G.I	GALVANIZED IRON
F.C.O	FLOOR CLEAN OUT

PLUMBING NOTE:-
 * W.C TO VERTICAL SOIL STACK 100Ø C.I SOIL PIPE
 * FLOOR TRAP TO VERTICAL WASTE STACK 100Ø C.I WASTE PIPE
 * FLOOR DRAIN TO FLOOR TRAP 50Ø G.I WASTE PIPE
 * WASH BASIN TO FLOOR TRAP 32Ø G.I WASTE PIPE
 * ALL WATER SUPPLY PIPES RUNNING AT VERTICAL SHAFT , TERRACE LEVEL & RUNNING AT CEILING LEVEL SHALL BE G.I PIPES & FITTINGS.
 * ALL WATER SUPPLY PIPES WITH IN THE TOILET, IN WALL CHASES SHALL BE "CPVC" PIPES & FITTINGS.
 * ALL VALVE UP TO 40mm DIA SHALL BE BALL VALVE.
 * ALL VALVE 50mm DIA & ABOVE SHALL BE BUTTER FLY VALVE.



THIS DRAWING IS THE PROPERTY OF THE DESIGN ASSOCIATES INC. AND SHALL NOT BE COPIED OR USED IN ANY MANNER WITHOUT PRIOR PERMISSION.

- NOTES:-
1. ALL DIMENSIONS ARE IN MM.
 2. ALL DIMENSIONS ARE TO BE READ AND NOT MEASURED.
 3. ALL LEVELS ARE IN MM.
 4. GRID DIMENSIONS AND PLOT LINES ARE TO BE STRICTLY ADHERED TO.
 5. ALL LEVELS INCLUDING FLOOR LEVELS, CHL & LINTEL LEVELS, LANDING LEVELS, PARAPET HEIGHT/ LEVELS, LEVELS OF HORIZONTAL PROJECTION & BONDS INCLUDING ANY SURFACE FEATURES INDICATED IN THE DRAWINGS ARE TO BE STRICTLY ADHERED TO.

MARK	DATE	DESCRIPTION

MEP CONSULTANT-
ARK CONSULTANTS
 1/30 ROSHAN GARDEN-II
 KAKROLA ROAD NAJAFGARH
 NEW DELHI-110043
 MOB:- 9599932606,9599932706
 E-MAIL-ark.mep2006@gmail.com

STRUCTURE CONSULTANT-
 CE CON ENGG.
 NEW DELHI

ARCHITECTS-
DESIGN ASSOCIATES INC.
 ARCHITECTURE
 A-163, Sector-136, Noida 201301
 PH. :0120-2428600, Fax: 0120-4778530
 e-mail: sachin.agarwal@designassociates.in

PROJECT-
 COMMERCIAL COMPLEX
 AT POLO MARKET
 SHILLONG


DRAWING TITLE-
 TERRACE PLAN
 (PLUMBING)

DRAWING PURPOSE-
 FOR TENDER PURPOSES ONLY

JOB NO. -	DWG. REF. NO. -	DATE-
---	---	05.10.2019
SCALE-	REVISION-	DATE OF ISSUE-
1:100	---	---

DWG. NO. -
 PM/CD/PL/107

SHEET SIZE- A3	SHEET NO- 01/01
DRAWN BY- V.K	CHECKED BY- A.G

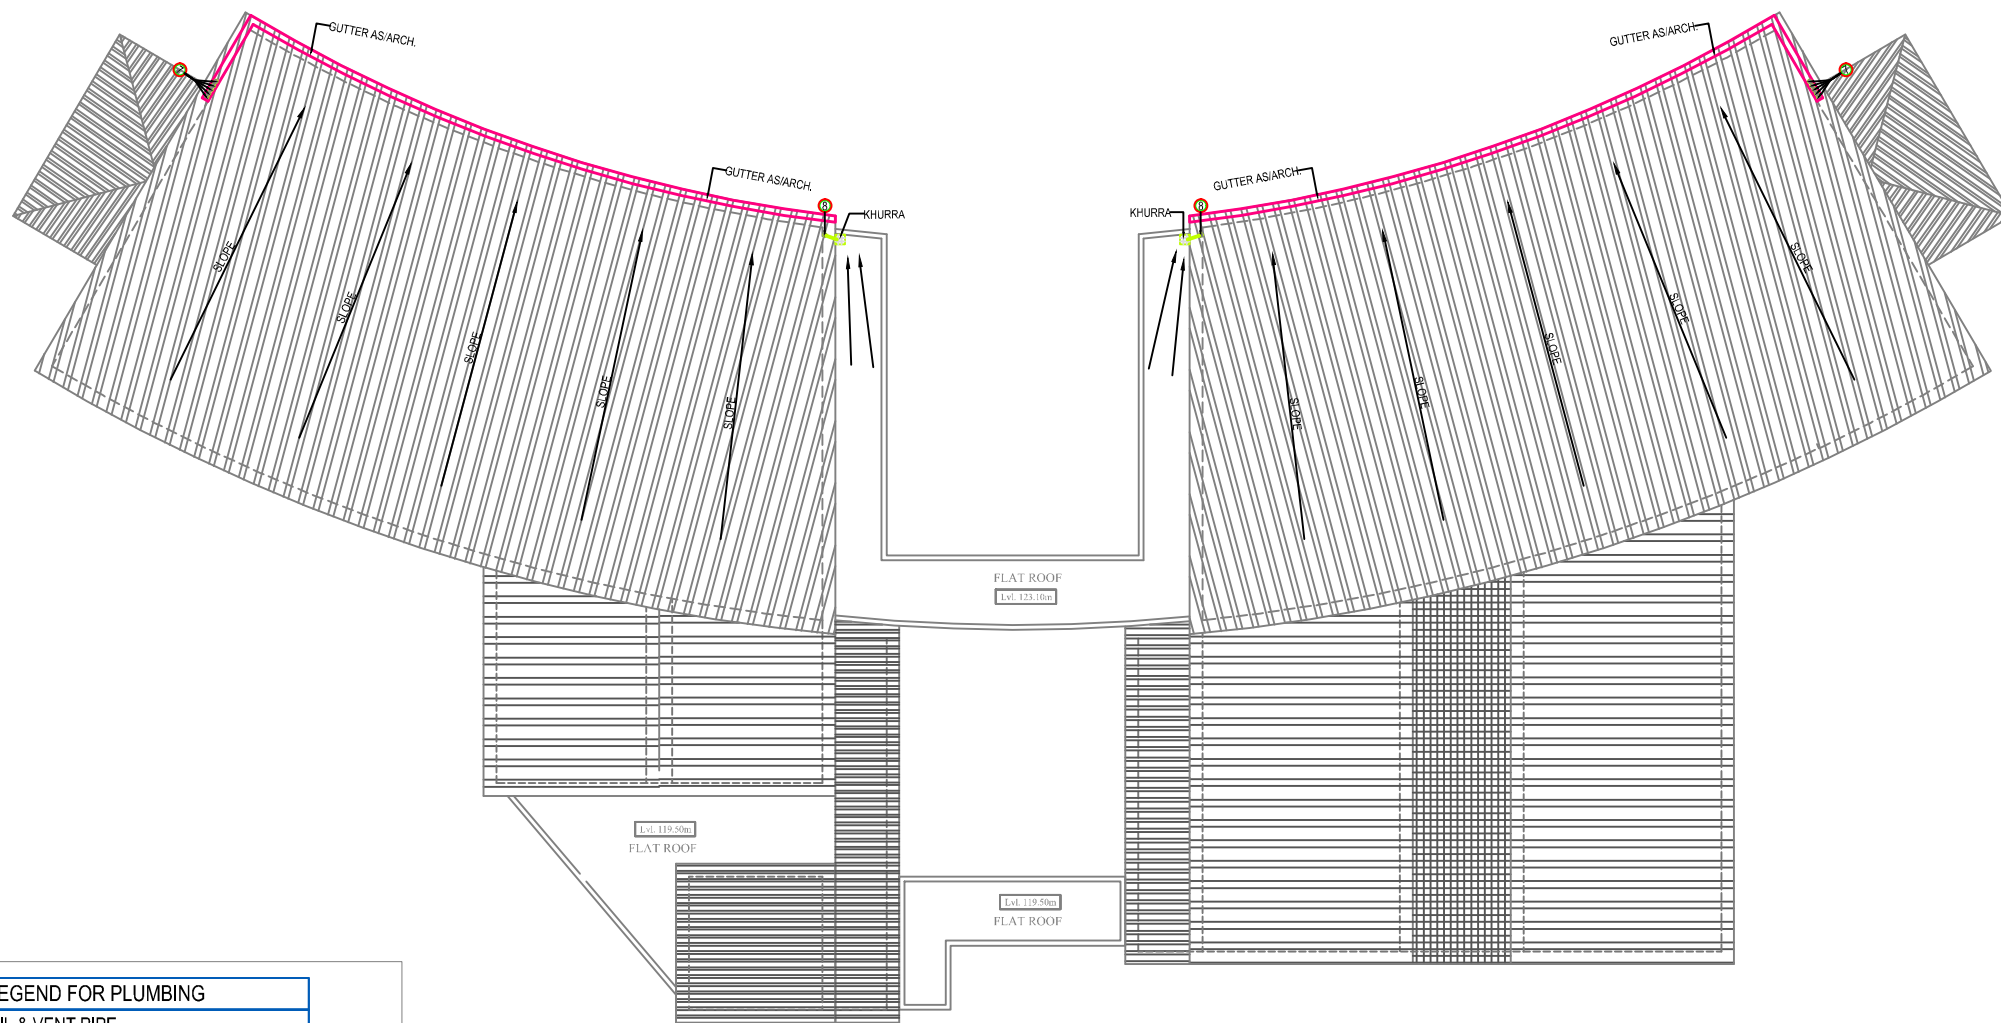

LEGEND FOR PLUMBING	
①	100Ø C.I SOIL & VENT PIPE
②	100Ø C.I WASTE & VENT PIPE
③	75Ø ANTI-SYPHONIC PIPE
④	DOMESTIC WATER SUPPLY PIPE
⑤	DOMESTIC WATER PIPE FROM O.H WATER TANK
⑥	FLUSHING WATER SUPPLY PIPE
⑦	160(OD)uPVC RAIN WATER PIPE
⑧	110(OD)uPVC RAIN WATER PIPE
F.T	FLOOR TRAP
F.D	FLOOR DRAIN
C.I	CAST IRON
G.I	GALVANIZED IRON
F.C.O	FLOOR CLEAN OUT

PLUMBING NOTE:-
 * W.C TO VERTICAL SOIL STACK 100Ø C.I SOIL PIPE
 * FLOOR TRAP TO VERTICAL WASTE STACK 100Ø C.I WASTE PIPE
 * FLOOR DRAIN TO FLOOR TRAP 50Ø G.I WASTE PIPE
 * WASH BASIN TO FLOOR TRAP 32Ø G.I WASTE PIPE
 * ALL WATER SUPPLY PIPES RUNNING AT VERTICAL SHAFT ,
 TERRACE LEVEL & RUNNING AT CEILING LEVEL SHALL
 BE G.I PIPES & FITTINGS.
 * ALL WATER SUPPLY PIPES WITH IN THE TOILET,
 IN WALL, CHASES SHALL BE "CPVC" PIPES & FITTINGS.
 * ALL VALVE UP TO 40mm DIA SHALL BE BALL VALVE.
 * ALL VALVE 50mm DIA & ABOVE SHALL BE BUTTER FLY VALVE.

ROOF PLAN

THIS DRAWING IS THE PROPERTY OF THE DESIGN ASSOCIATES INC. AND SHALL NOT BE COPIED OR USED IN ANY MANNER WITHOUT PRIOR PERMISSION.

- NOTES:-
1. ALL DIMENSIONS ARE IN MM.
 2. ALL DIMENSIONS ARE TO BE READ AND NOT MEASURED.
 3. ALL LEVELS ARE IN MM.
 4. GRID DIMENSIONS AND PLOT LINES ARE TO BE STRICTLY ADHERED TO.
 5. ALL LEVELS INCLUDING FLOOR LEVELS, CILL & LINTEL LEVELS, LANDING LEVELS, PARAPET HEIGHT/ LEVELS, LEVELS OF HORIZONTAL PROJECTION & BONDS INCLUDING ANY SURFACE FEATURES INDICATED IN THE DRAWINGS ARE TO BE STRICTLY ADHERED TO.

MARK	DATE	DESCRIPTION

MEP CONSULTANT-
ARK CONSULTANTS
 1/30 ROSHAN GARDEN-II
 KAKROLA ROAD NAJAFGARH
 NEW DELHI-110043
 MOB:- 9599932606,9599932706
 E-MAIL-ark.mep2006@gmail.com

STRUCTURE CONSULTANT-
 CE CON ENGG.
 NEW DELHI


ARCHITECTS-
DESIGN ASSOCIATES INC.
 ARCHITECTURE
 A-163, Sector-136, Noida 201301
 PH. :0120-2428600, Fax: 0120-4778530
 e-mail: sachin.agarwal@designassociates.in

PROJECT-
 COMMERCIAL COMPLEX
 AT POLO MARKET
 SHILLONG

DRAWING TITLE-
 GROUND FLOOR PLAN
 (PLUMBING)

DRAWING PURPOSE-
 FOR TENDER PURPOSES ONLY

JOB NO. -	DWG. REF. NO. -	DATE-
---	---	05.10.2019
SCALE-	REVISION-	DATE OF ISSUE-
1:100	---	---
DWG. NO. -		
PM/CD/PL/102		
SHEET SIZE-	SHEET NO-	
A3	01/01	
DRAWN BY-	CHECKED BY-	
V.K	A.G	

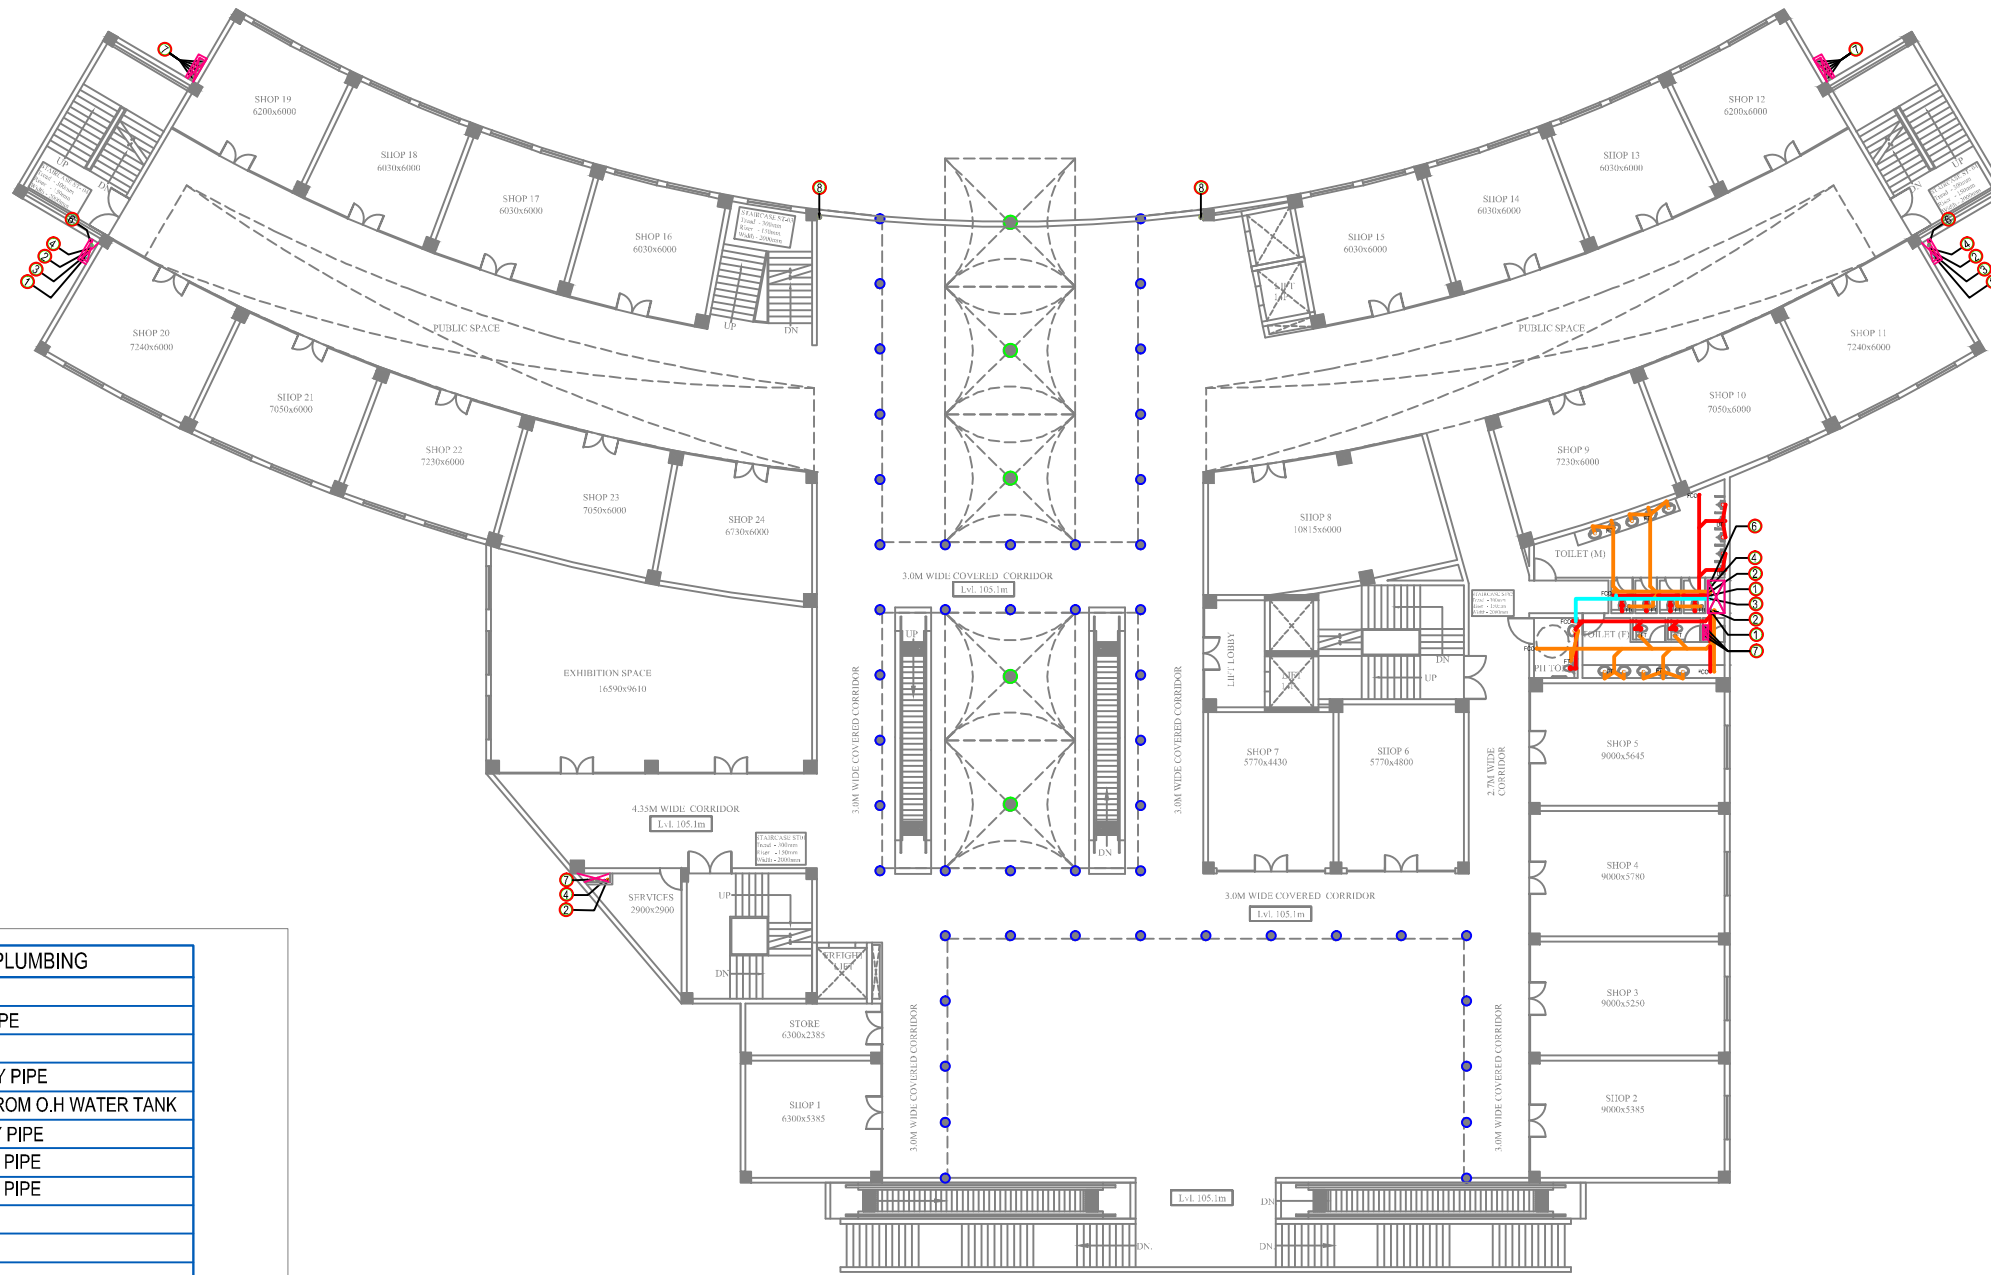

GROUND FLOOR PLAN

LEGEND FOR PLUMBING	
①	100Ø C.I SOIL & VENT PIPE
②	100Ø C.I WASTE & VENT PIPE
③	75Ø ANTI-SYPHONIC PIPE
④	DOMESTIC WATER SUPPLY PIPE
⑤	DOMESTIC WATER PIPE FROM O.H WATER TANK
⑥	FLUSHING WATER SUPPLY PIPE
⑦	160(OD)uPVC RAIN WATER PIPE
⑧	110(OD)uPVC RAIN WATER PIPE
F.T	FLOOR TRAP
F.D	FLOOR DRAIN
C.I	CAST IRON
G.I	GALVANIZED IRON
F.C.O	FLOOR CLEAN OUT

- PLUMBING NOTE:-
- * W.C TO VERTICAL SOIL STACK 100Ø C.I SOIL PIPE
 - * FLOOR TRAP TO VERTICAL WASTE STACK 100Ø C.I WASTE PIPE
 - * FLOOR DRAIN TO FLOOR TRAP 50Ø G.I WASTE PIPE
 - * WASH BASIN TO FLOOR TRAP 32Ø G.I WASTE PIPE
 - * ALL WATER SUPPLY PIPES RUNNING AT VERTICAL SHAFT, TERRACE LEVEL & RUNNING AT CEILING LEVEL SHALL BE G.I PIPES & FITTINGS.
 - * ALL WATER SUPPLY PIPES WITH IN THE TOILET, IN WALL, CHASES SHALL BE "CPVC" PIPES & FITTINGS.
 - * ALL VALVE UP TO 40mm DIA SHALL BE BALL VALVE.
 - * ALL VALVE 50mm DIA & ABOVE SHALL BE BUTTER FLY VALVE.

